



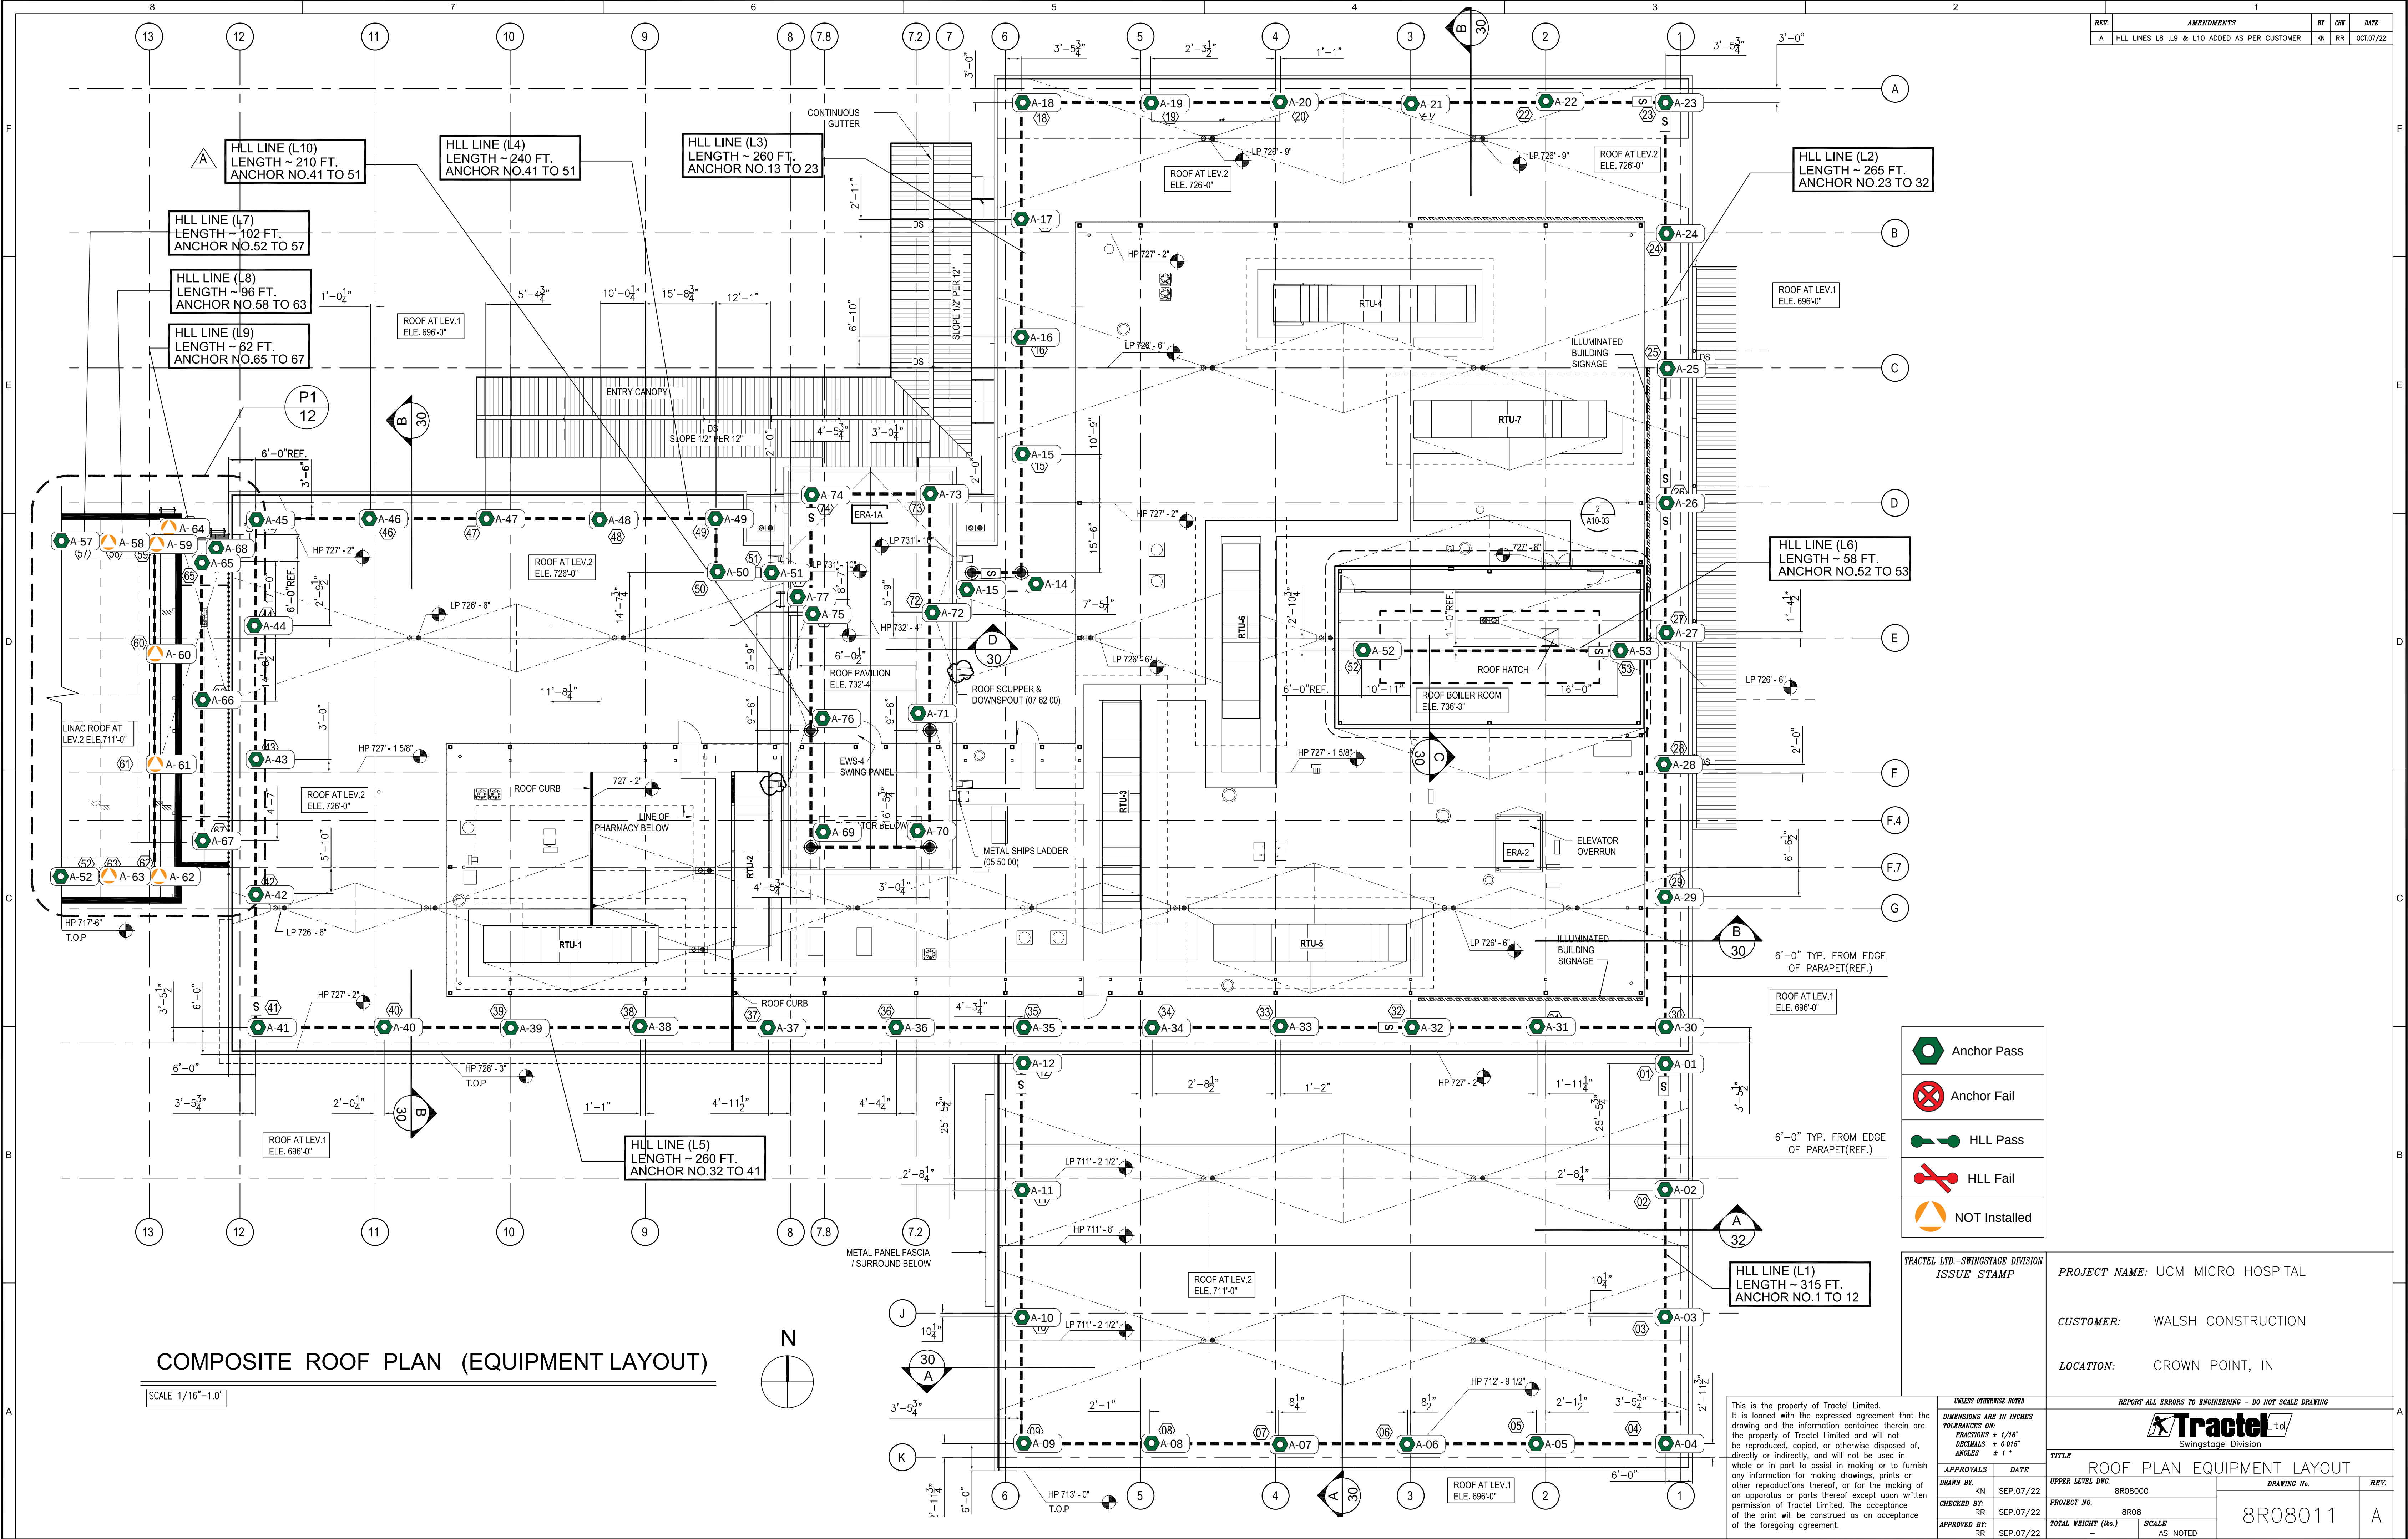

COMPOSITE ROOF PLAN (EQUIPMENT LAYOUT)

SCALE 1/16"=1.0'

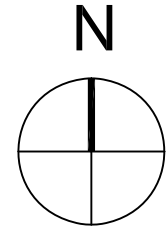

- Anchor Pass
- Anchor Fail
- HLL Pass
- HLL Fail
- NOT Installed


TRACTEL LTD.-SWINGSTAGE DIVISION
ISSUE STAMP

PROJECT NAME: UCM MICRO HOSPITAL
CUSTOMER: WALSH CONSTRUCTION
LOCATION: CROWN POINT, IN

This is the property of Tractel Limited. It is loaned with the expressed agreement that the drawing and the information contained therein are the property of Tractel Limited and will not be reproduced, copied, or otherwise disposed of, directly or indirectly, and will not be used in whole or in part to assist in making or to furnish any information for making drawings, prints or other reproductions thereof, or for the making of an apparatus or parts thereof except upon written permission of Tractel Limited. The acceptance of the print will be construed as an acceptance of the foregoing agreement.

UNLESS OTHERWISE NOTED	
DIMENSIONS ARE IN INCHES	
TOLERANCES ON:	
FRACTIONS ± 1/16"	
DECIMALS ± 0.015"	
ANGLES ± 1°	
APPROVALS	DATE
DRAWN BY: KN	SEP.07/22
CHECKED BY: RR	SEP.07/22
APPROVED BY: RR	SEP.07/22

REPORT ALL ERRORS TO ENGINEERING - DO NOT SCALE DRAWING			
Swingstage Division			
TITLE: ROOF PLAN EQUIPMENT LAYOUT			
APPROVALS	DATE	UPPER LEVEL DWG: 8R08000	DRAWING No.
DRAWN BY: KN	SEP.07/22	PROJECT No. 8R08	REV. 1
CHECKED BY: RR	SEP.07/22	TOTAL WEIGHT (lbs.)	8R08011
APPROVED BY: RR	SEP.07/22	SCALE AS NOTED	A

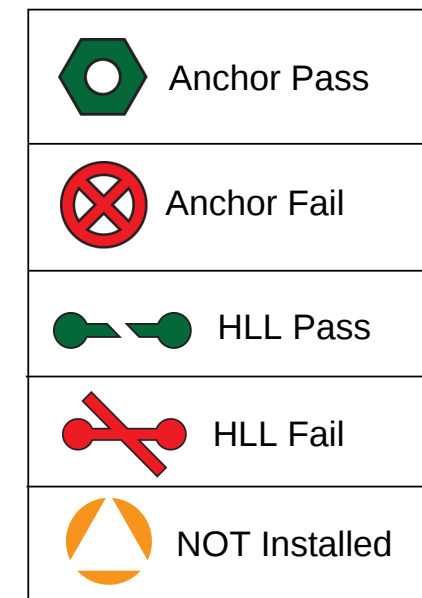

REPORT ALL ERRORS TO ENGINEERING - DO NOT SCALE DRAWING			A
 Swingstage Division			
TITLE			
ROOF PLAN EQUIPMENT LAYOUT			
UPPER LEVEL SWG	8R0800D	DRAWING No.	REV.
PROJECT No.		8R08012	-
TOTAL WEIGHT (lbs.)	8R08		
SCALE	AS NOTED		